


# D Block - Ground floor

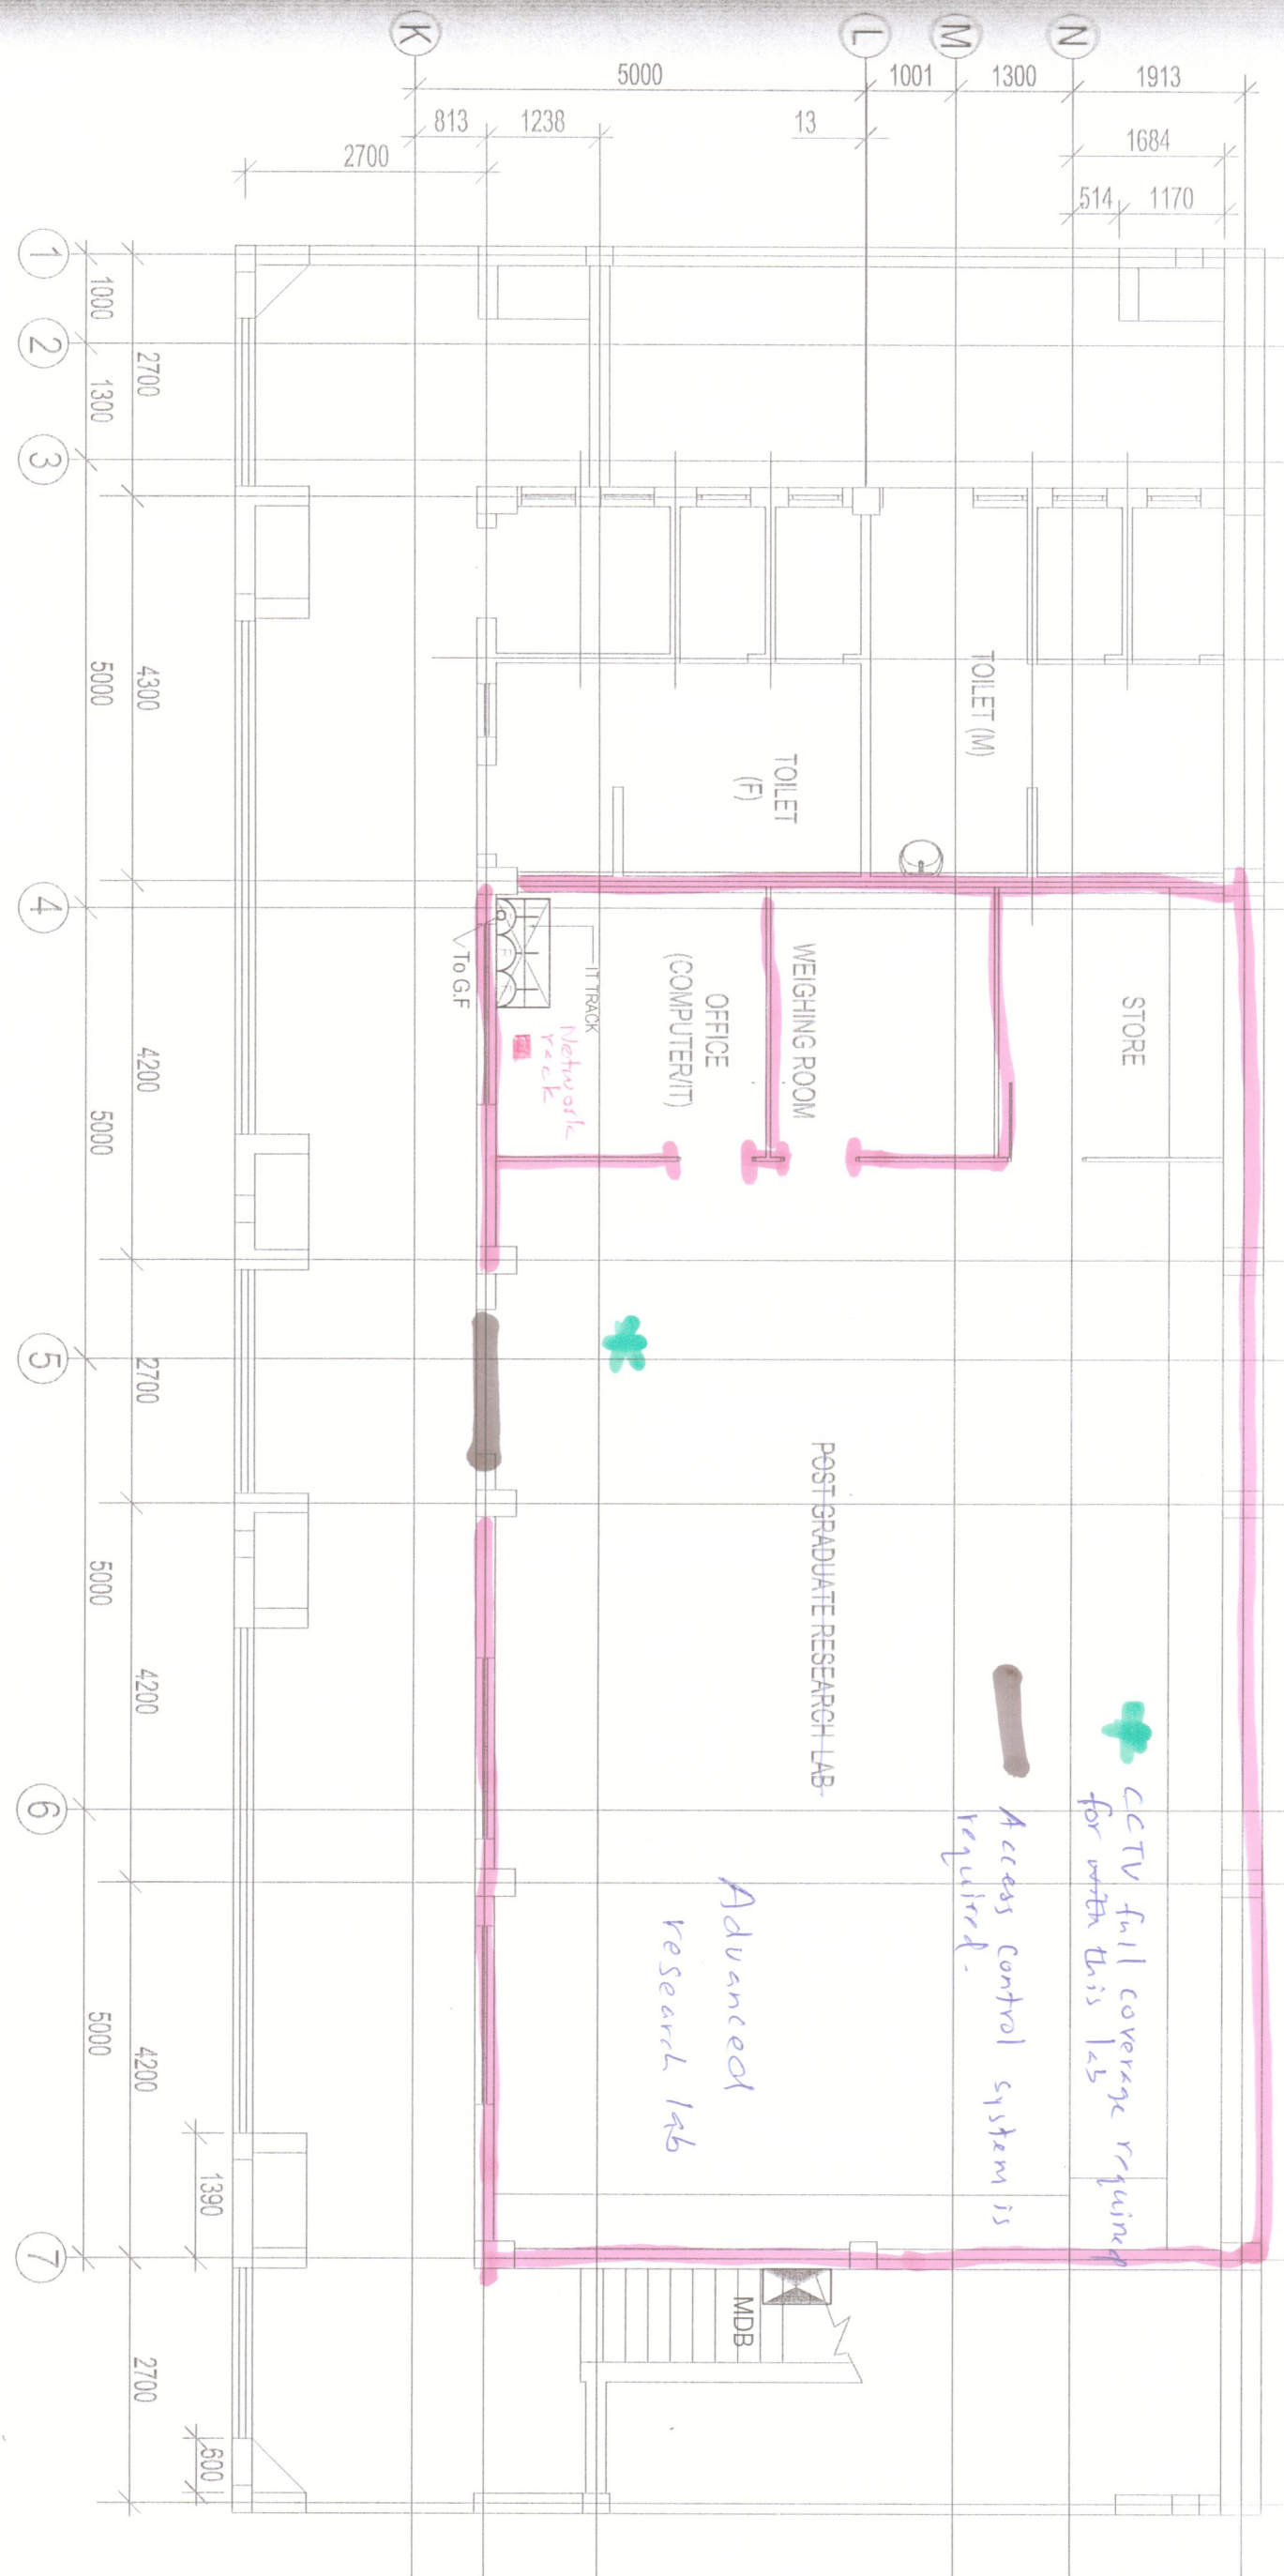

CCTV full coverage required for water lab  
 Access control system is required.

Advanced research lab

Network rack  
 IT TRACK  
 To G.F.

Client  
 DEBACATING SOCIETY TRUST OF SRI LANKA  
 UNIVERSITY GRANTS COMMISSION

Project  
 BLOCK D


Drawing Title  
 AS BUILT DRAWING OF  
 IT ARRANGEMENT  
 BASEMENT FLOOR

ENGINEERS  
 ARCHITECTS  
 QS/CPD

E.P.C. DIVISION  
 CENTRAL ENGINEERING CONSULTANTS' ASSOCIATION  
 100/1, RAJAPALLE

D-11175  
 D/1115-BLOCK D-I.T-011(A/SB)



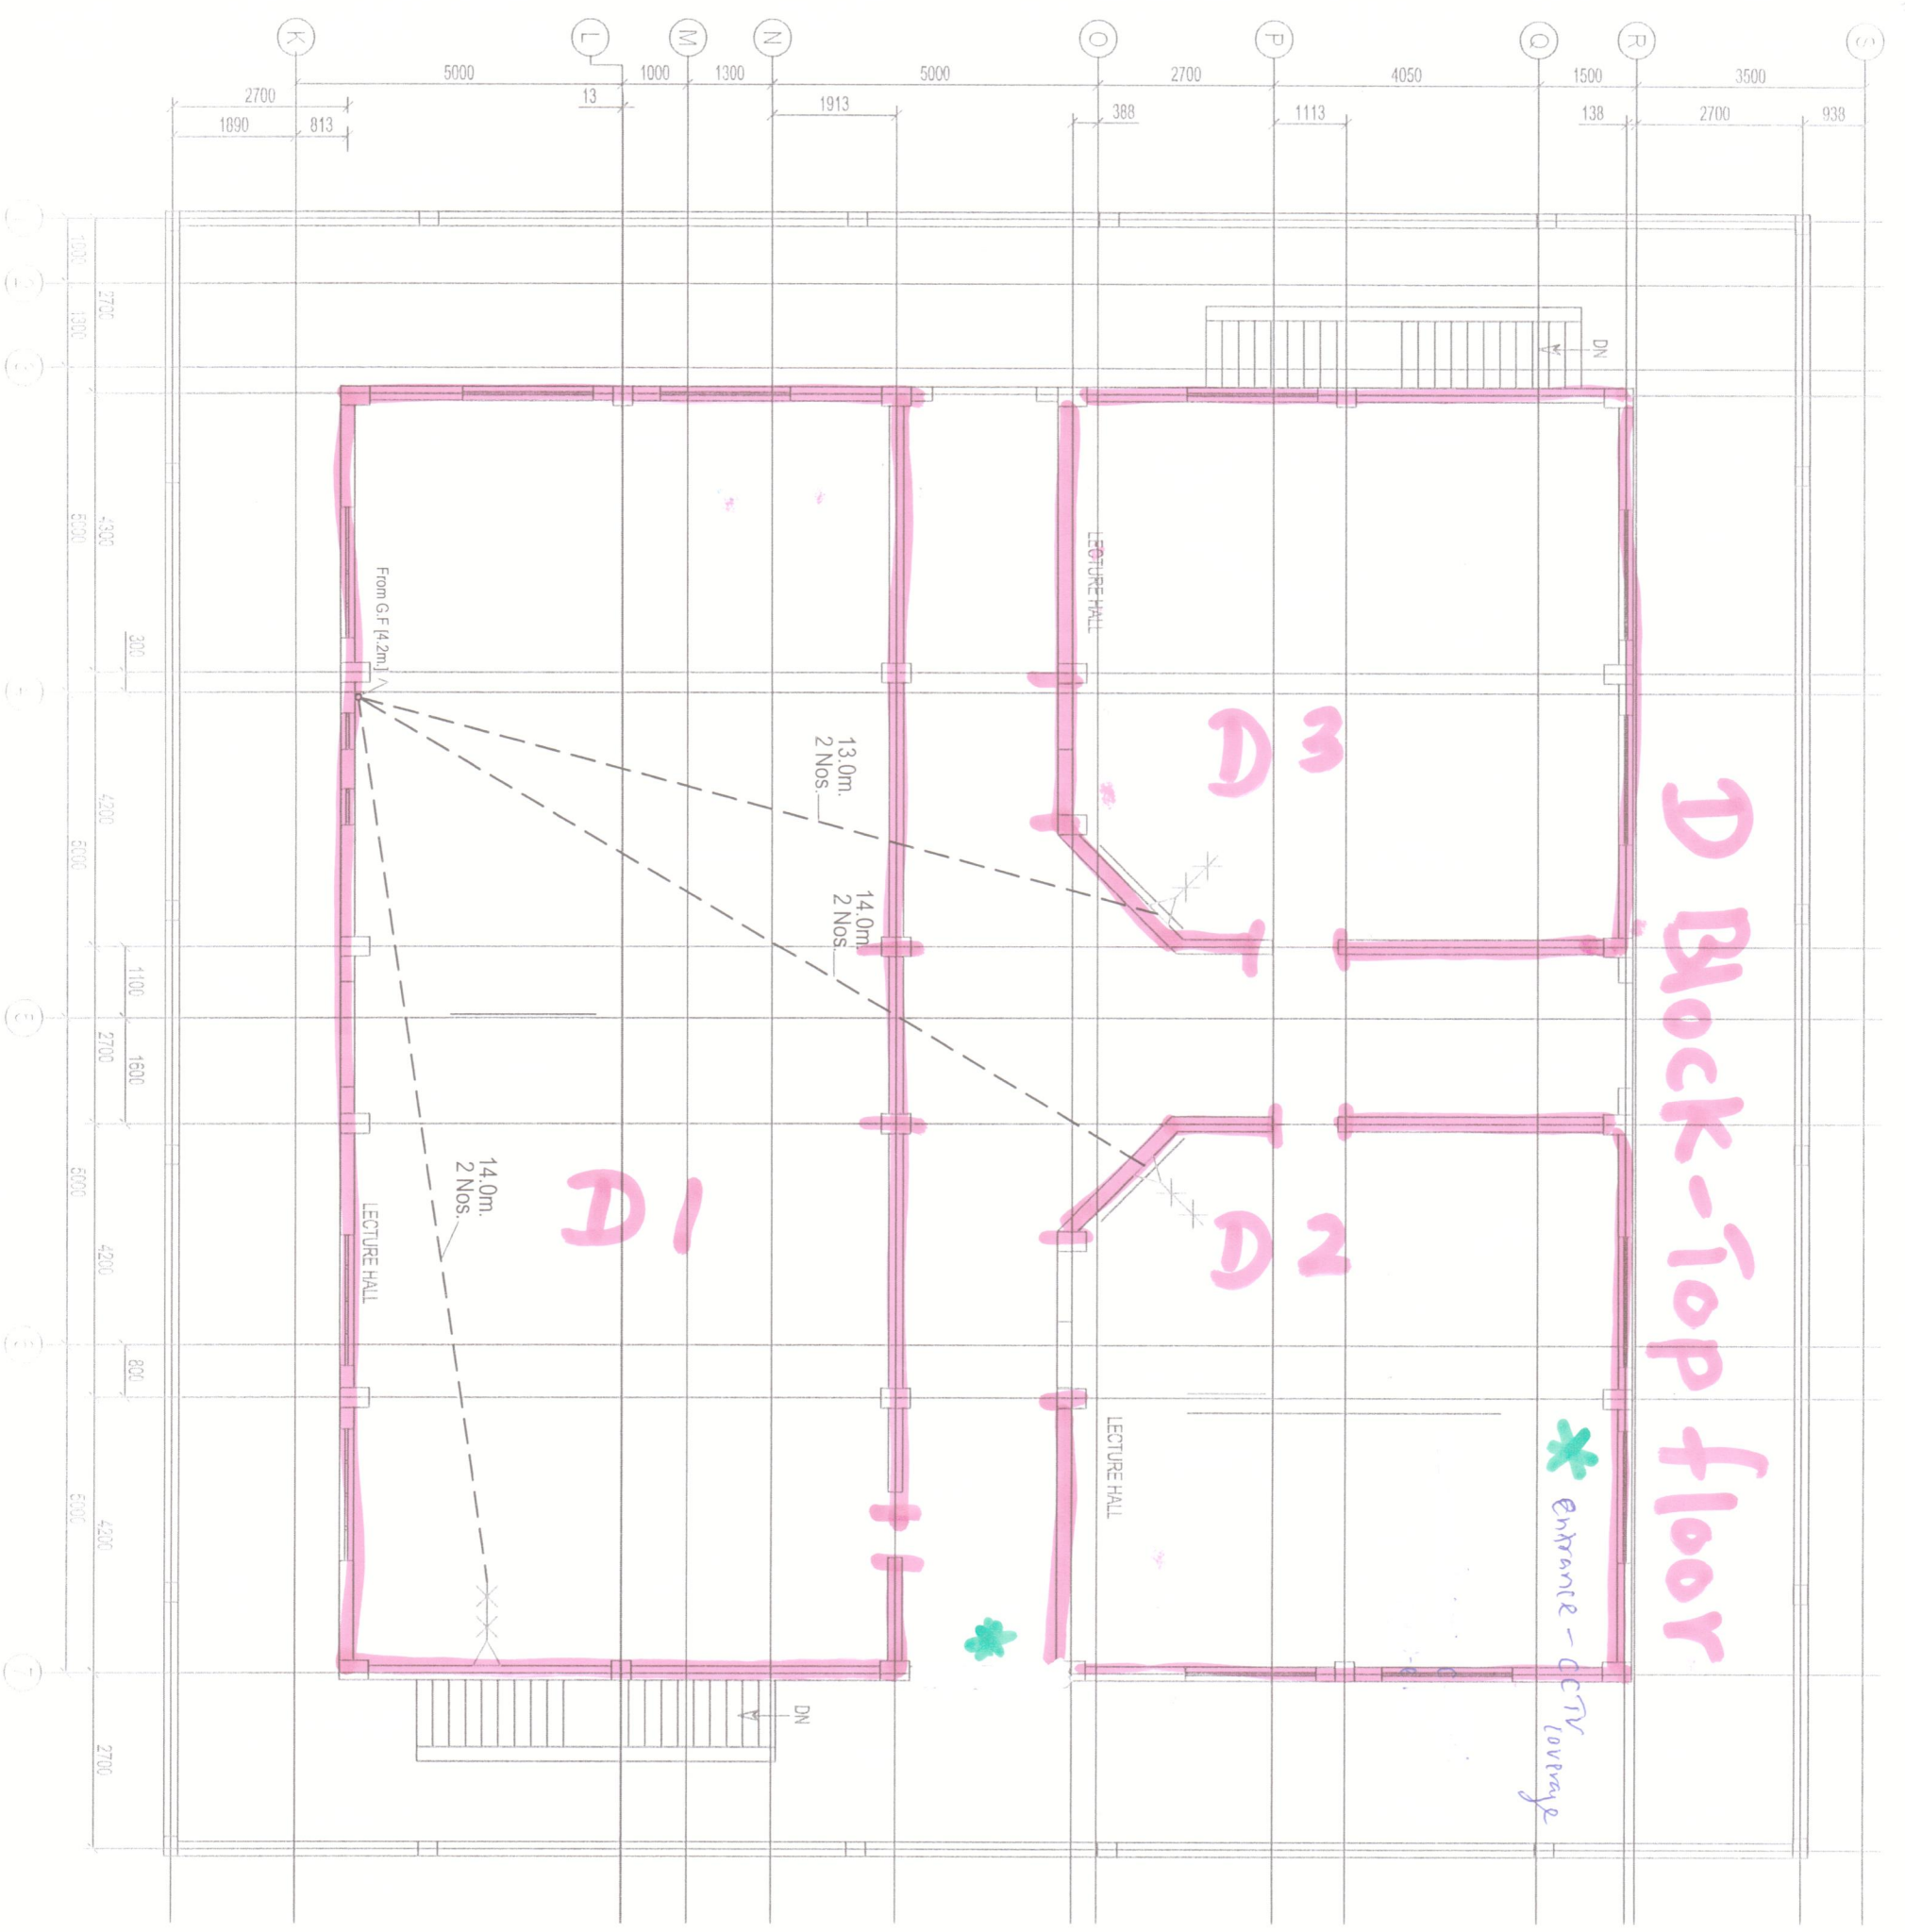

LEGEND:

◇××× - DUAL OUTLET (M)

Client  
DEPARTMENT OF QUALITY IMPROVEMENT SERVICES  
UNIVERSITY GRANTS COMMISSION


Project:  
**BLOCK D**

Drawing Title:  
**AS BUILT DRAWING OF  
IT ARRANGEMENT  
UPPER FLOOR**

ENGINEERS  
ARCHITECTS  
QS/QSD

E.P.C. DIVISION  
CENTRAL ENGINEERING CONSULTANCY SERVICES  
DIAGRAM BUILDING

D-1175 D1175-BLOCK-D-IT-001(ASB)

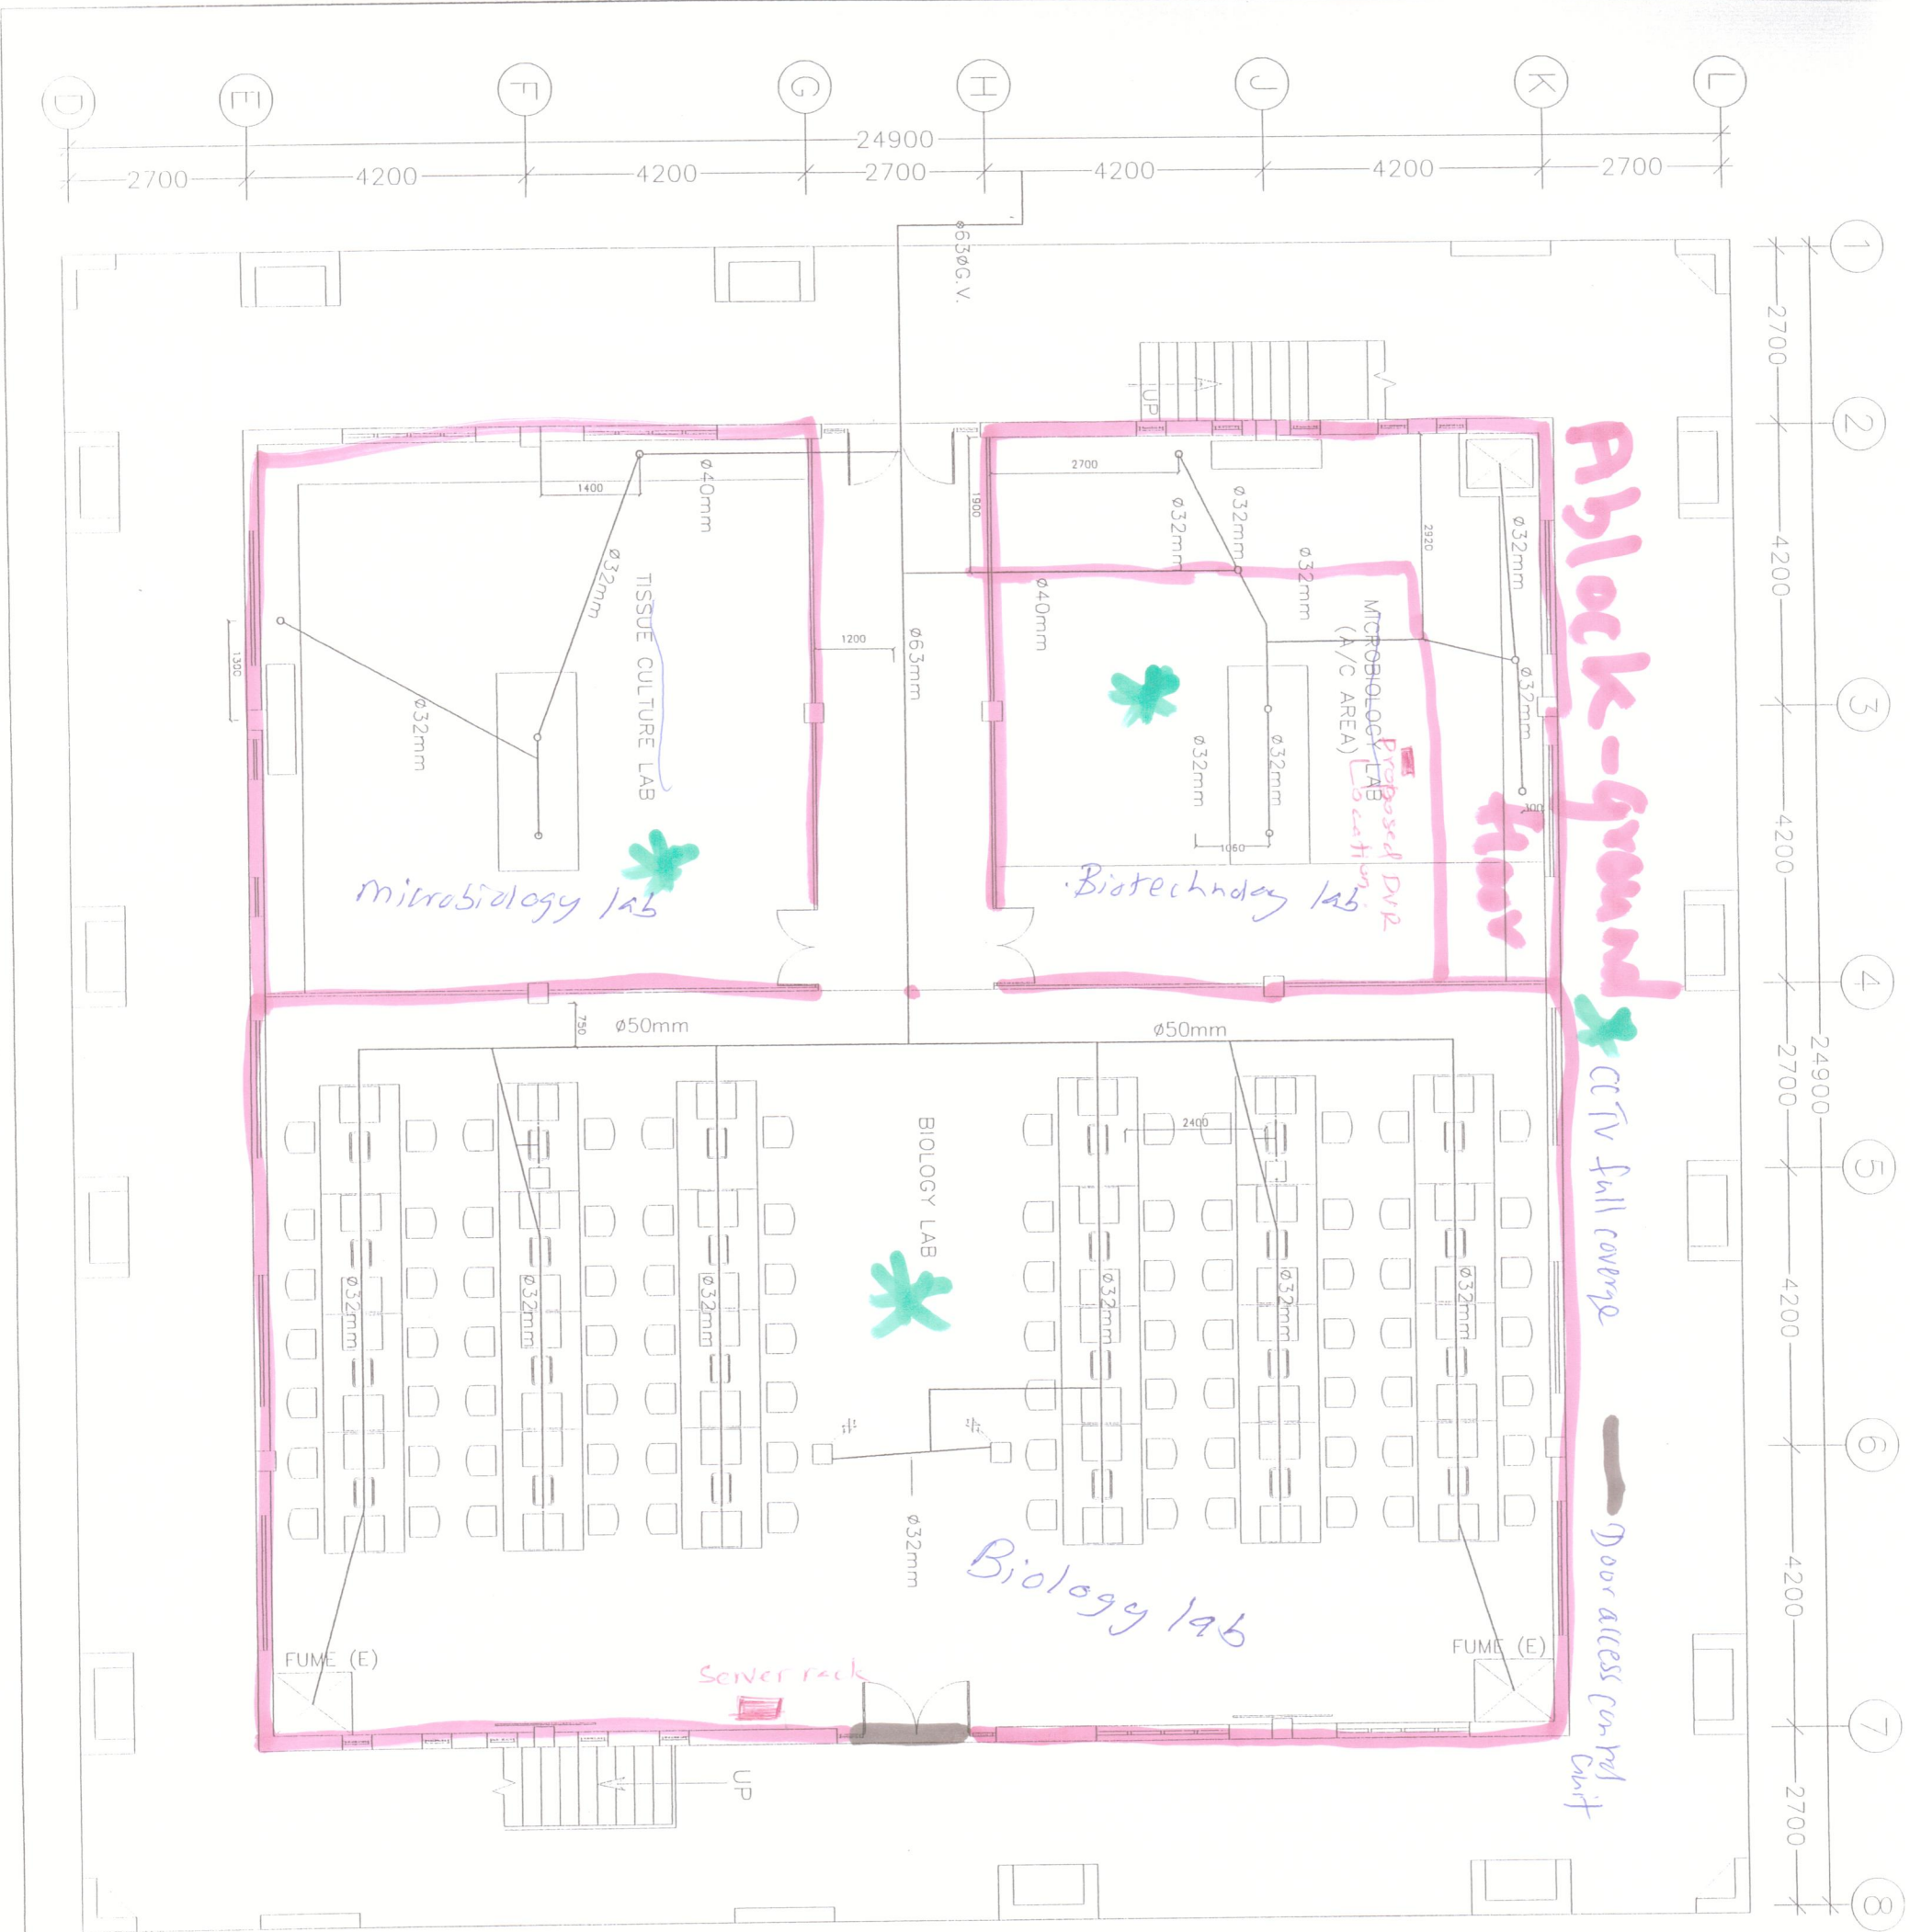

**Block-G ground floor**

CCTV full coverage

Door access control unit

Microbiology lab

Biotechnology lab

Biology lab

TISSUE CULTURE LAB

Proposed DVR (A/C AREA)

sewer rack


FUME (E)

FUME (E)

WATER SUPPLY LINE

THE DEMOCRATIC SOCIALIST REPUBLIC OF SRI LANKA  
 UNIVERSITY GRANTS COMMISSION  
 UVA WELLISSA UNIVERSITY AT BADULLA  
 FACULTY LECTURE HALL & LAB COMPLEX  
 BLOCK A  
 GROUND FLOOR  
 WATER SUPPLY SYSTEM

DESIGNED BY	DATE	APPROVED BY
DRN M W	APRIL 2007	[Signature]
CHECKED BY	SCALE	DATE
[Signature]	N.T.S	APRIL 2007
CONSULTANTS		
CENTRAL ENGINEERING CONSULTANCY BUREAU		
415, RAJAPALAYA, MAWLA THA, COLOMBO 11 - SRI LANKA		
DRAWING NO: C662-1-1-15-01 [ASE]		

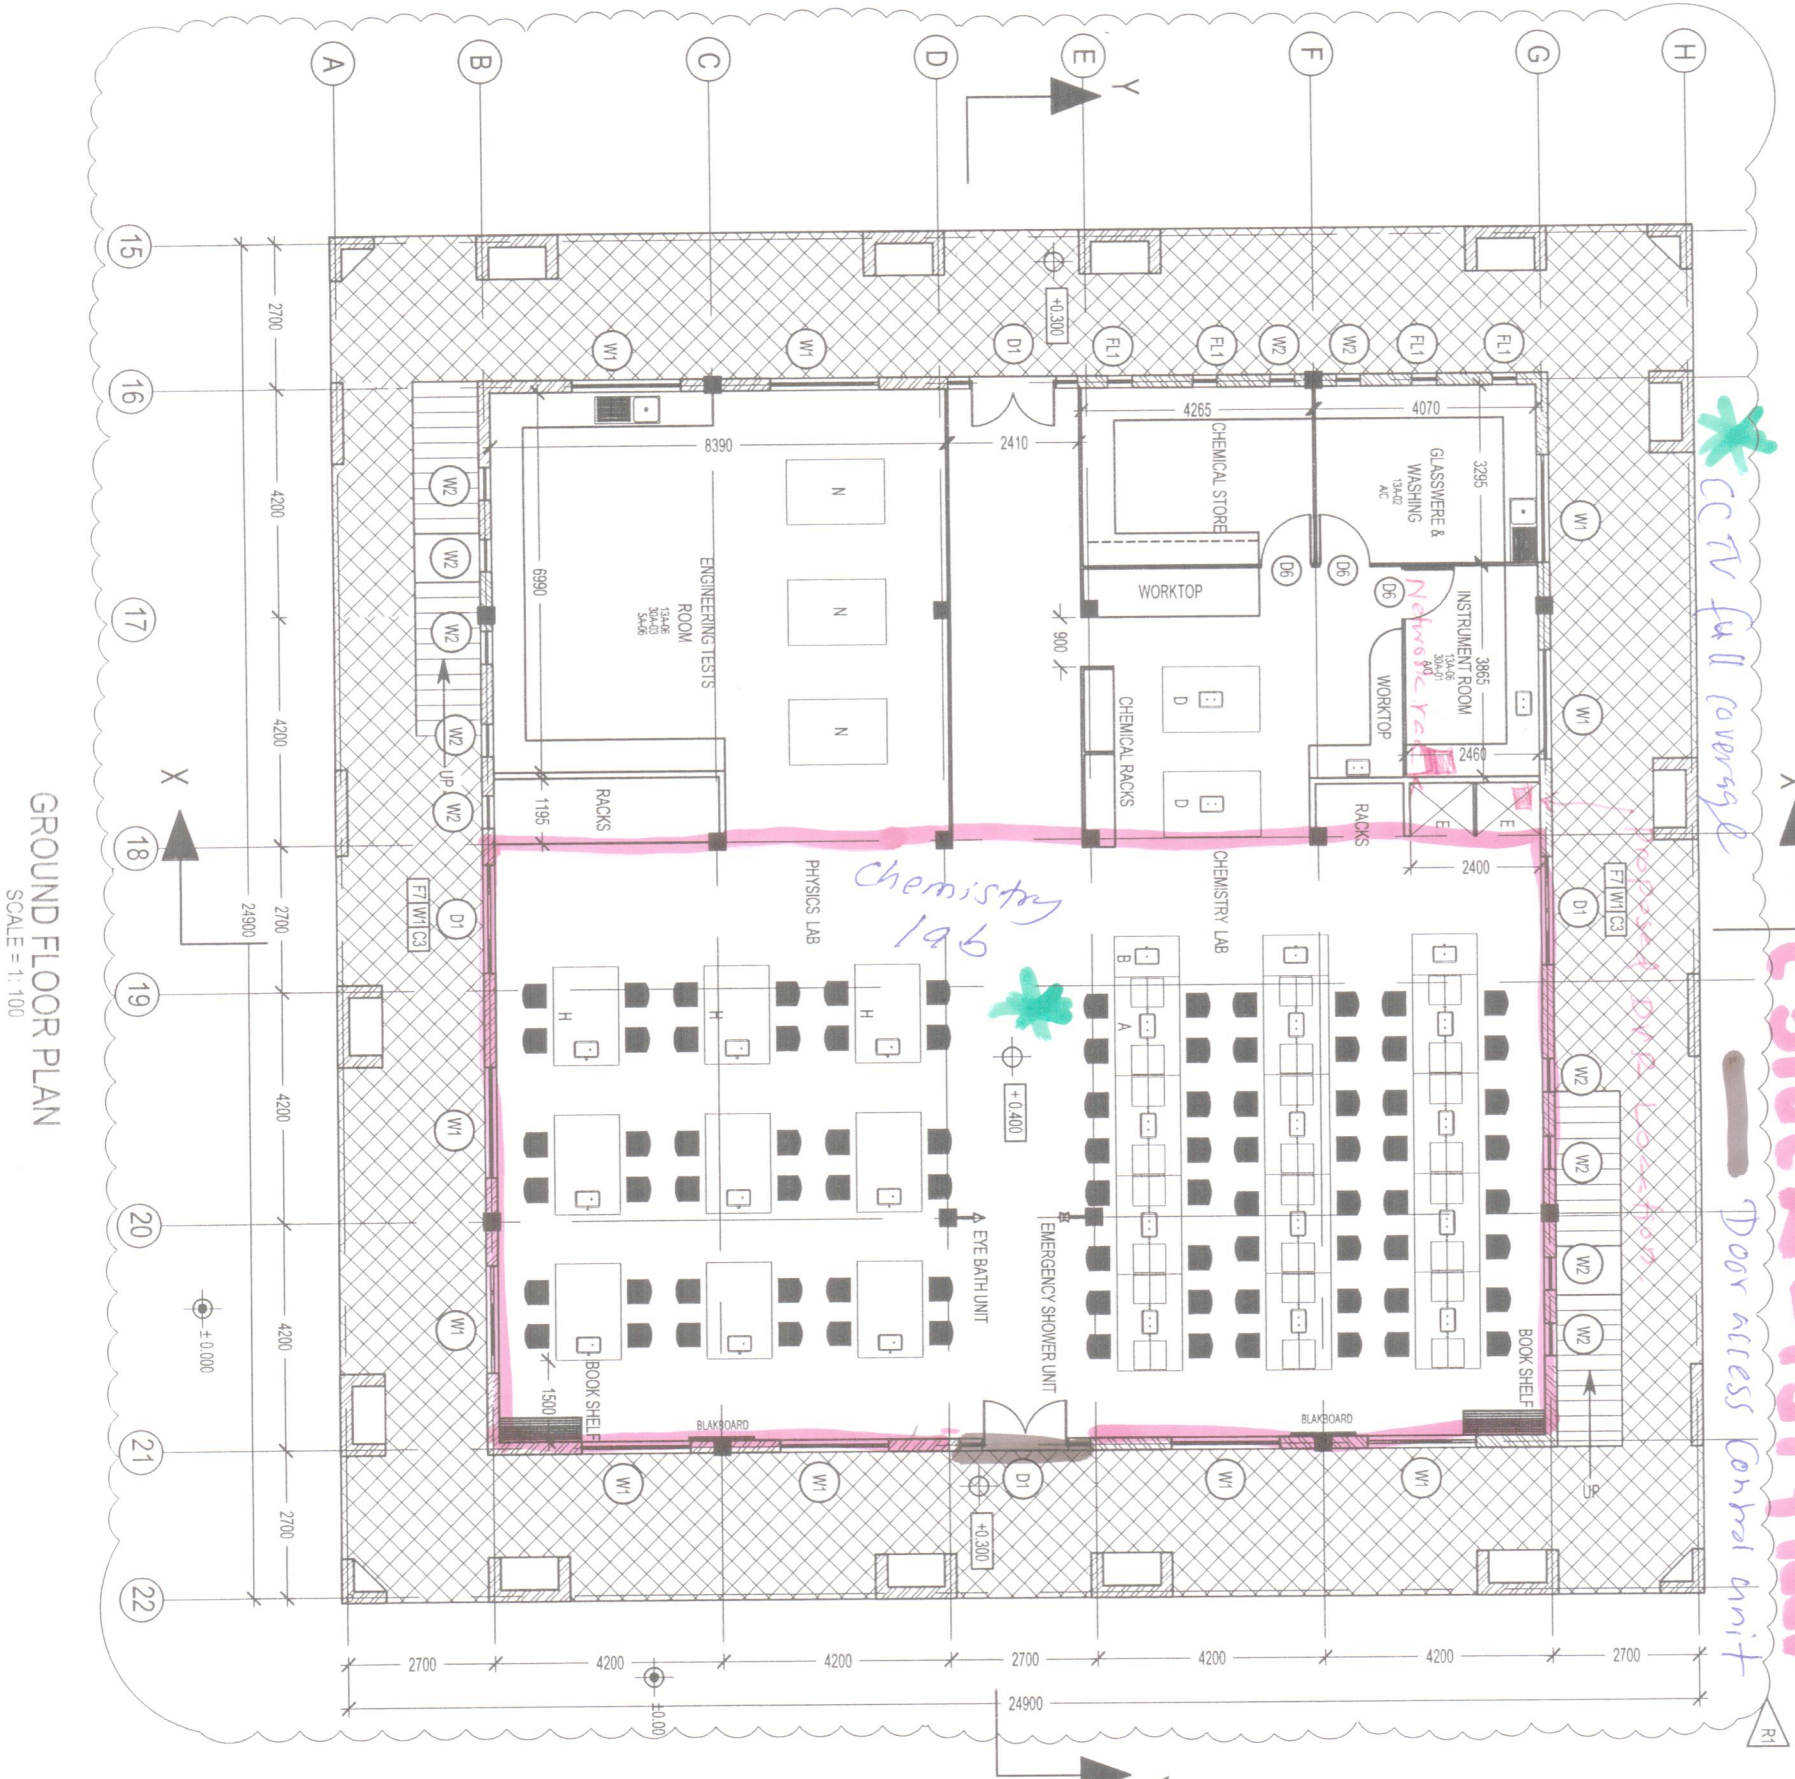

GROUND FLOOR PLAN  
SCALE = 1:100


*CCTV full coverage*

*Block - 1st floor*

*Door access control unit*

*Chemistry Lab*

- GENERAL NOTES
1. ALL DIMENSIONS ARE GIVEN IN MILLIMETERS AND LEVELS ARE GIVEN IN METERS UNLESS OTHERWISE STATED.
  2. ALL HEIGHTS ARE GIVEN FROM FINISH FLOOR LEVEL.
  3. ALL DIMENSIONS ARE GIVEN TO ROUGH EDGES OF THE BASIC BUILDING STRUCTURE COMPRISING OF R.C. AND BRICK WORK ETC. EXCEPT THE DIMENSIONS WITHIN BRACKETS WHICH ARE GIVEN TO THE FINISHED EDGES UNLESS OTHERWISE STATED OR TO AXIS.
  4. DRAWINGS ARE NOT TO BE SCALED FOR CONSTRUCTION PURPOSES.
  5. ANY DISCREPANCY BETWEEN ARCHITECTURAL DRAWINGS AND STRUCTURAL MECHANICAL AND ELECTRICAL DRAWINGS OR ANY OTHER ITEM SHOULD BE BROUGHT TO NOTICE OF CONSULTANT FOR CLARIFICATION AND FINALISATION.
  6. FINISHES ARE SHOWN AS INDICATED BELOW

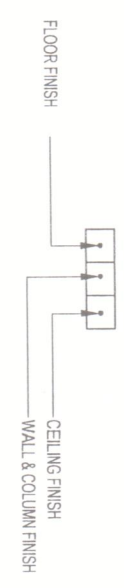

- FURNITURE TYPES
- A - LAB TABLE WITH RACKS
  - B - SINK TABLE
  - D - DEMONSTRATION TABLE
  - E - FUME CLIPBOARD
  - H - LAB TABLE WITHOUT RACKS

Rev	Date	By	Description	Chk'd	App'd

THE DEMOCRATIC SOCIALIST REPUBLIC OF SRI LANKA  
UNIVERSITY GRANT COMMISSION

PROPOSED LECTURE HALL AND LAB COMPLEX  
UVA WELLASSA UNIVERSITY AT BADULLA  
BLOCK - C  
GROUND FLOOR  
FURNITURE LAYOUT


**ENGINEERS & ARCHITECTS**  
**Cecb**  
ARCHITECTURAL UNIT

**CENTRAL ENGINEERING CONSULTANCY BUREAU**

Head Office  
415, Bandulahaka Mawatha  
Colombo-07700, Sri Lanka  
Tel. 0094-11-2668800. Fax. 0094-11-2668800.  
E-Mail: cecb@silk.lk


Project Office  
ARCHITECTURAL UNIT

Designed	Recommended
Drawn	H.W.S
Dwg Checked	Approved - DGM (ARCHI)
Submitted	Scale SCALE 1:100
CAD File	MSP III-1, D: DRAWING OFFICE
Sheet Size	A2
Drawing No	C662-LH/AR/UR/SP/14
Date	20/04/06
Status	C

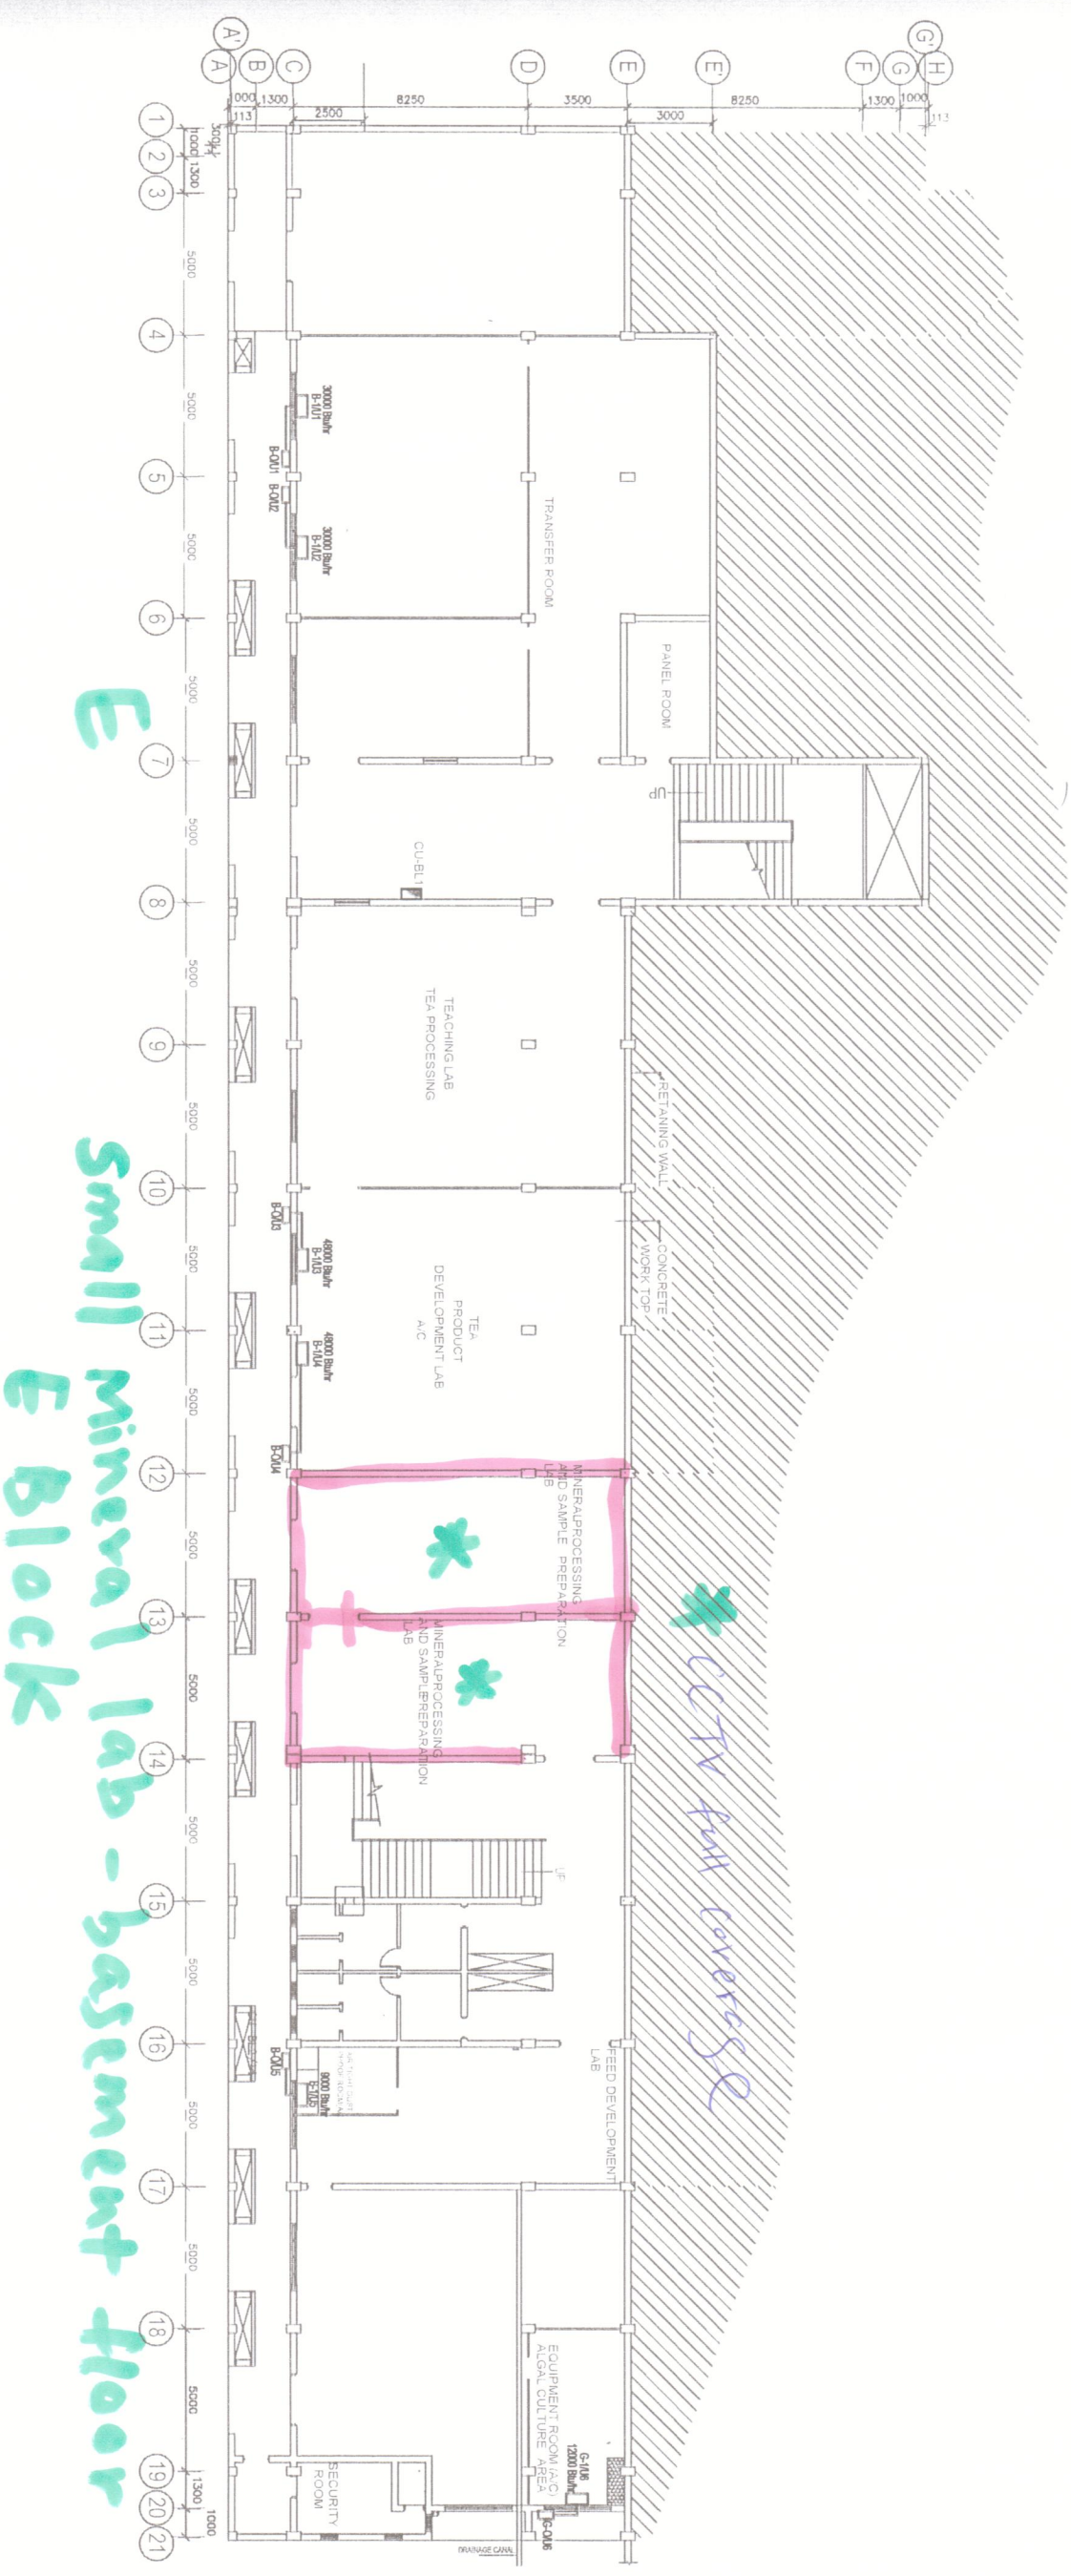

- A/C
- A/C BOX
- A/C BOX

Client	DEMOCRATIC SOCIALIST REPUBLIC OF SRI LANKA UNIVERSITY GRANTS COMMISSION
Project	<b>BLOCK - E</b>
Drawing Title	AS BUILT DRAWING OF INSTALLATION OF AIR CONDITIONING SYSTEM BASEMENT FLOOR
Engineers	 CECB CIVIL ENGINEERING CONSULTANTS COLLEGE BOULEVARD COLOMBO 03, SRI LANKA
Scale	AS SHOWN
Author	
Checked	
Drawn	
Date	2018/08/21

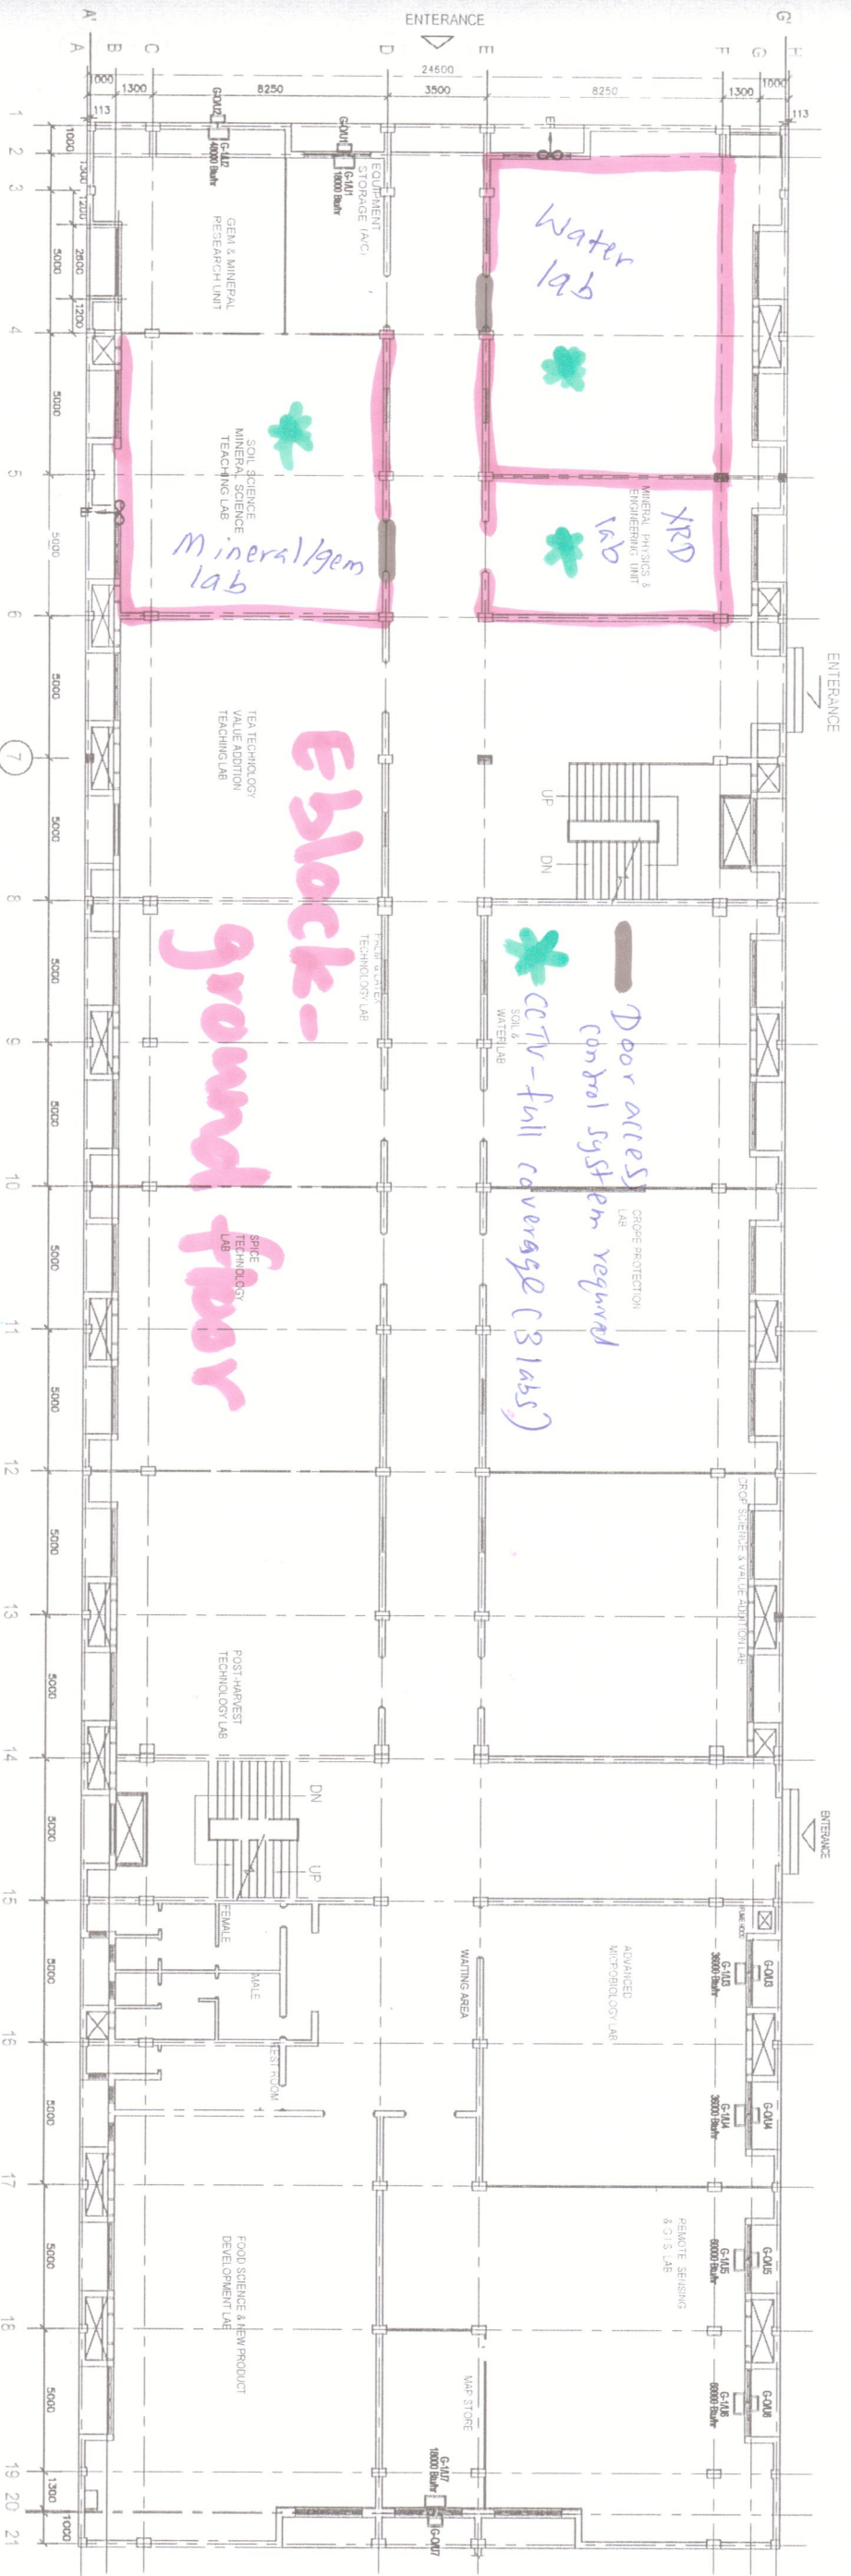

**Block - ground floor**

Door access control system required  
CCTV - full coverage (81455)

EF-8

Client: DEMOCRATIC SOCIALIST REPUBLIC OF SRI LANKA UNIVERSITY GRANTS COMMISSION

Project: **BLOCK - E**

AS BUILT DRAWING OF INSTALLATION OF AIR CONDITIONING SYSTEM GROUND FLOOR

ENGINEERS ASSOCIATION OF SRI LANKA

*Handwritten signature and date*



